



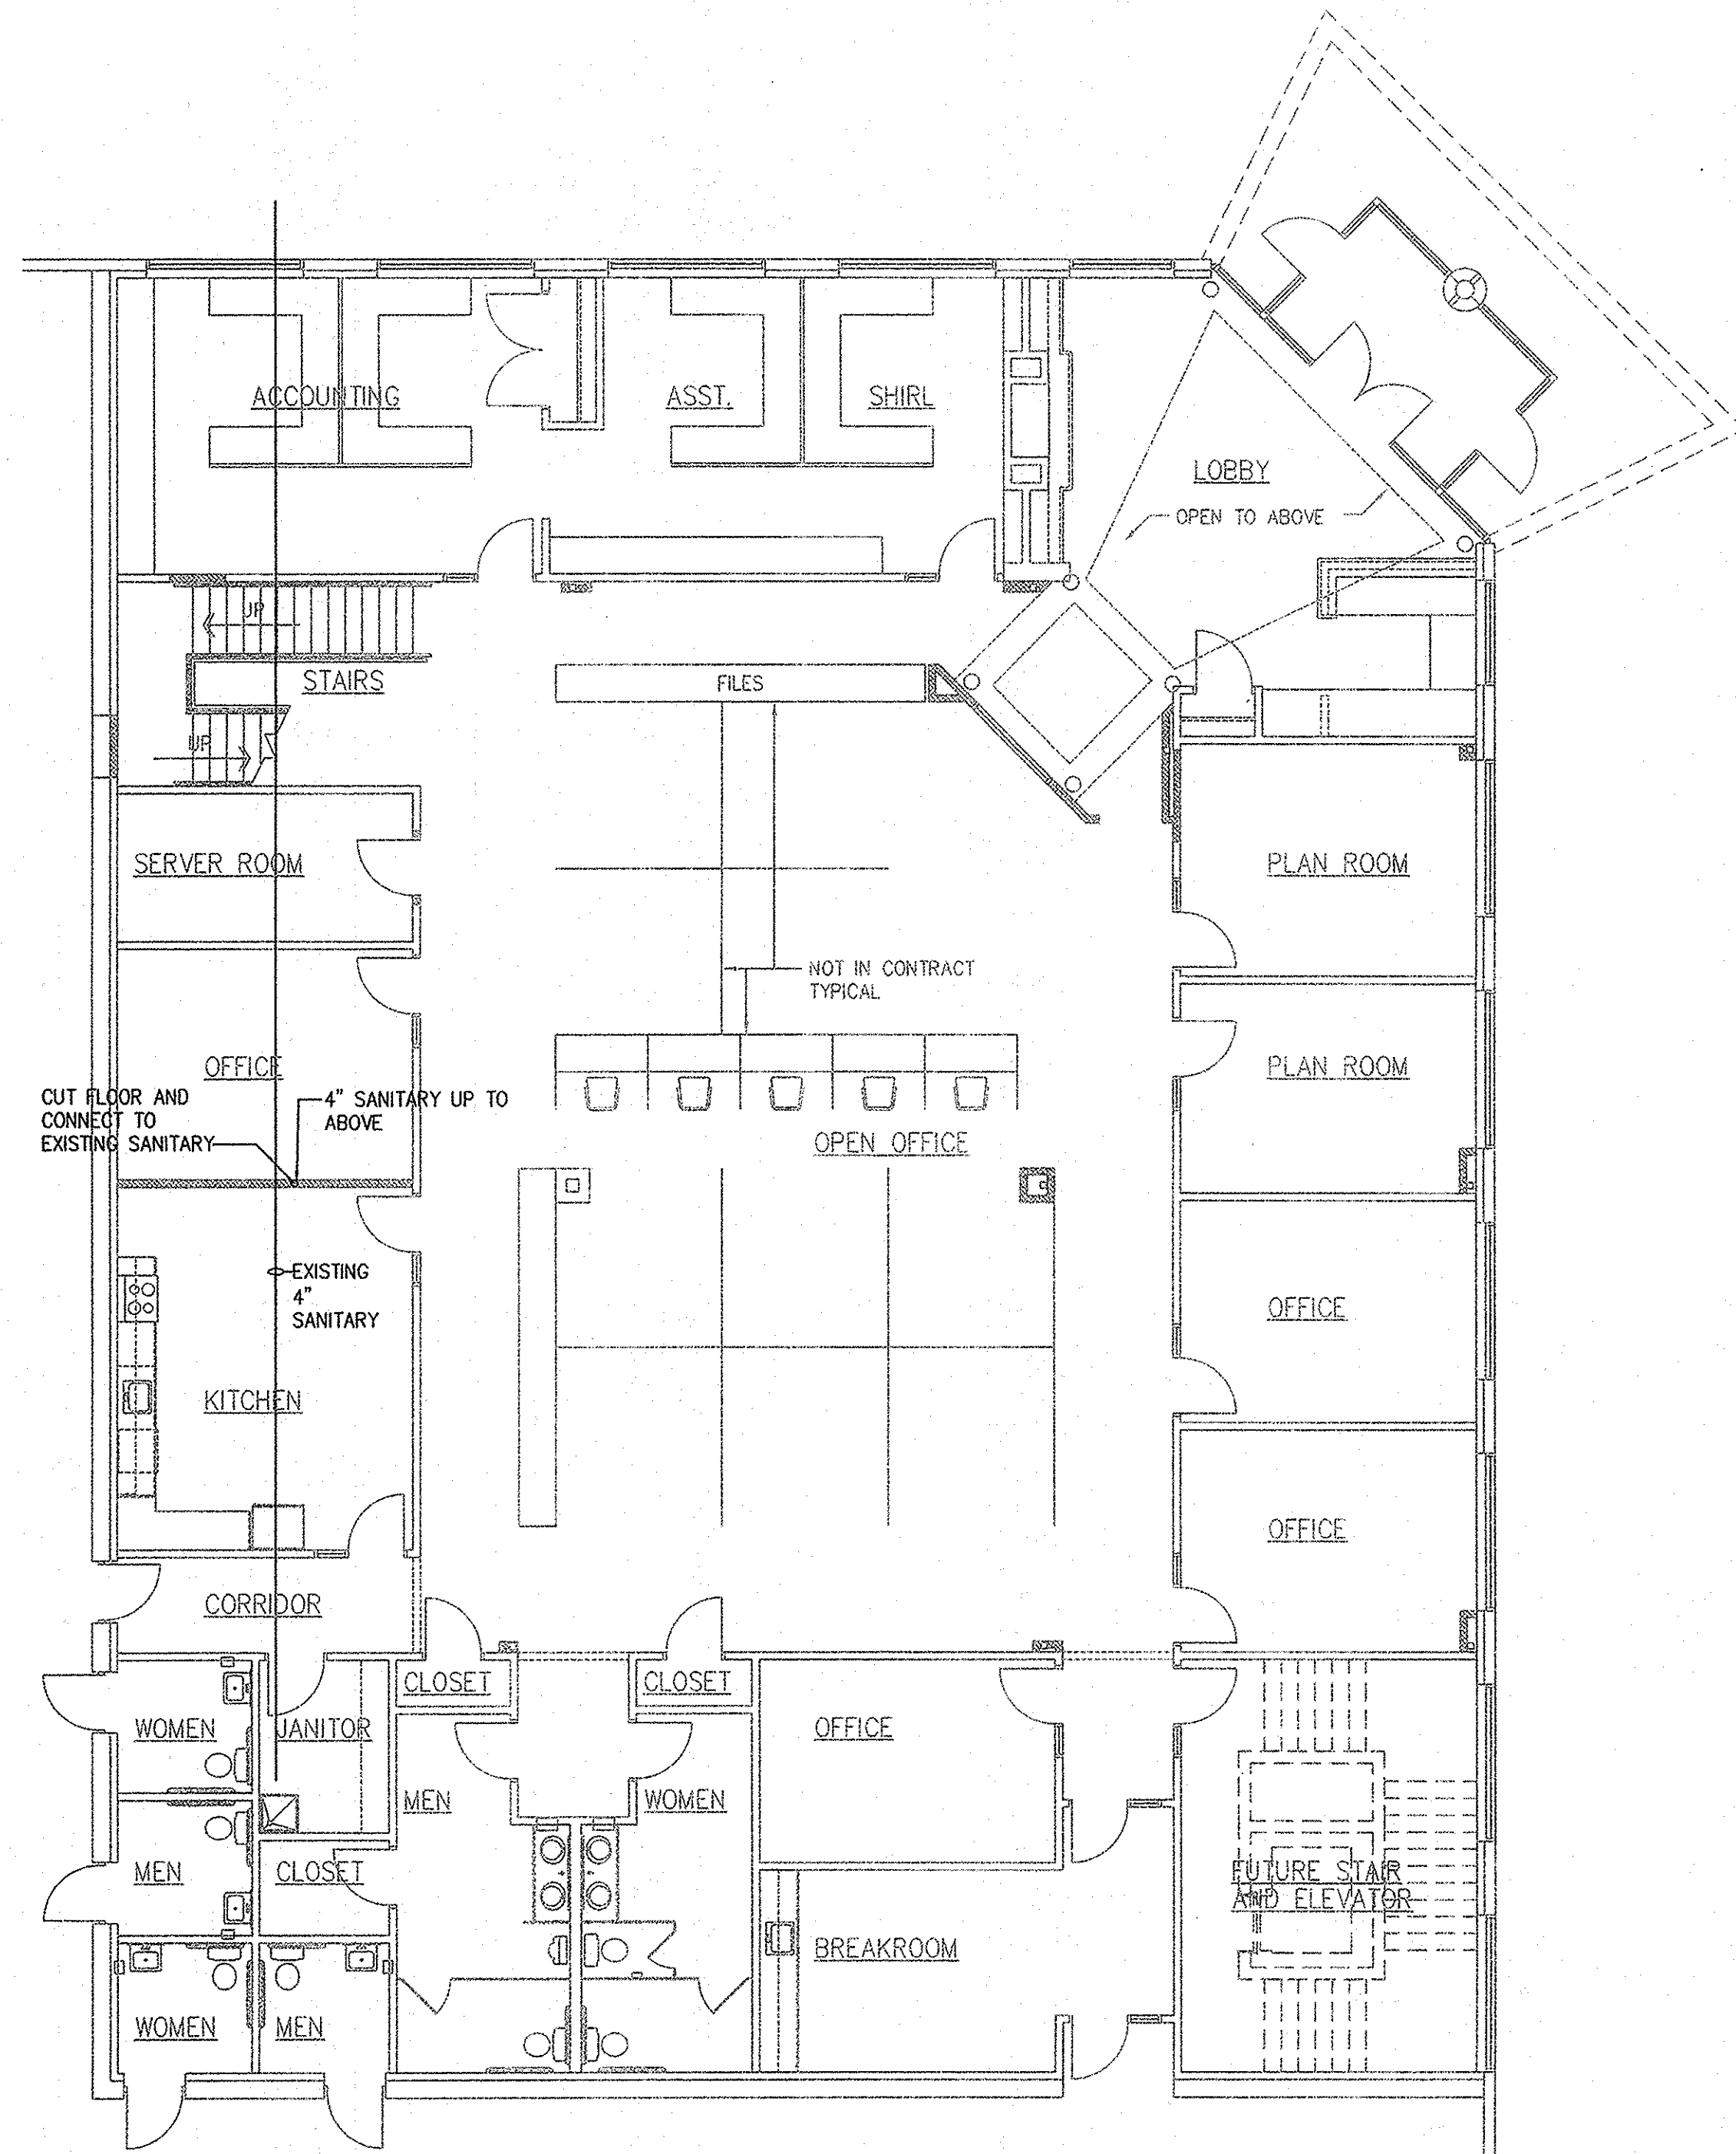

PARTIAL FIRST FLOOR PLAN – INTERIOR FITOUT
SCALE: 1/8"=1'-0"

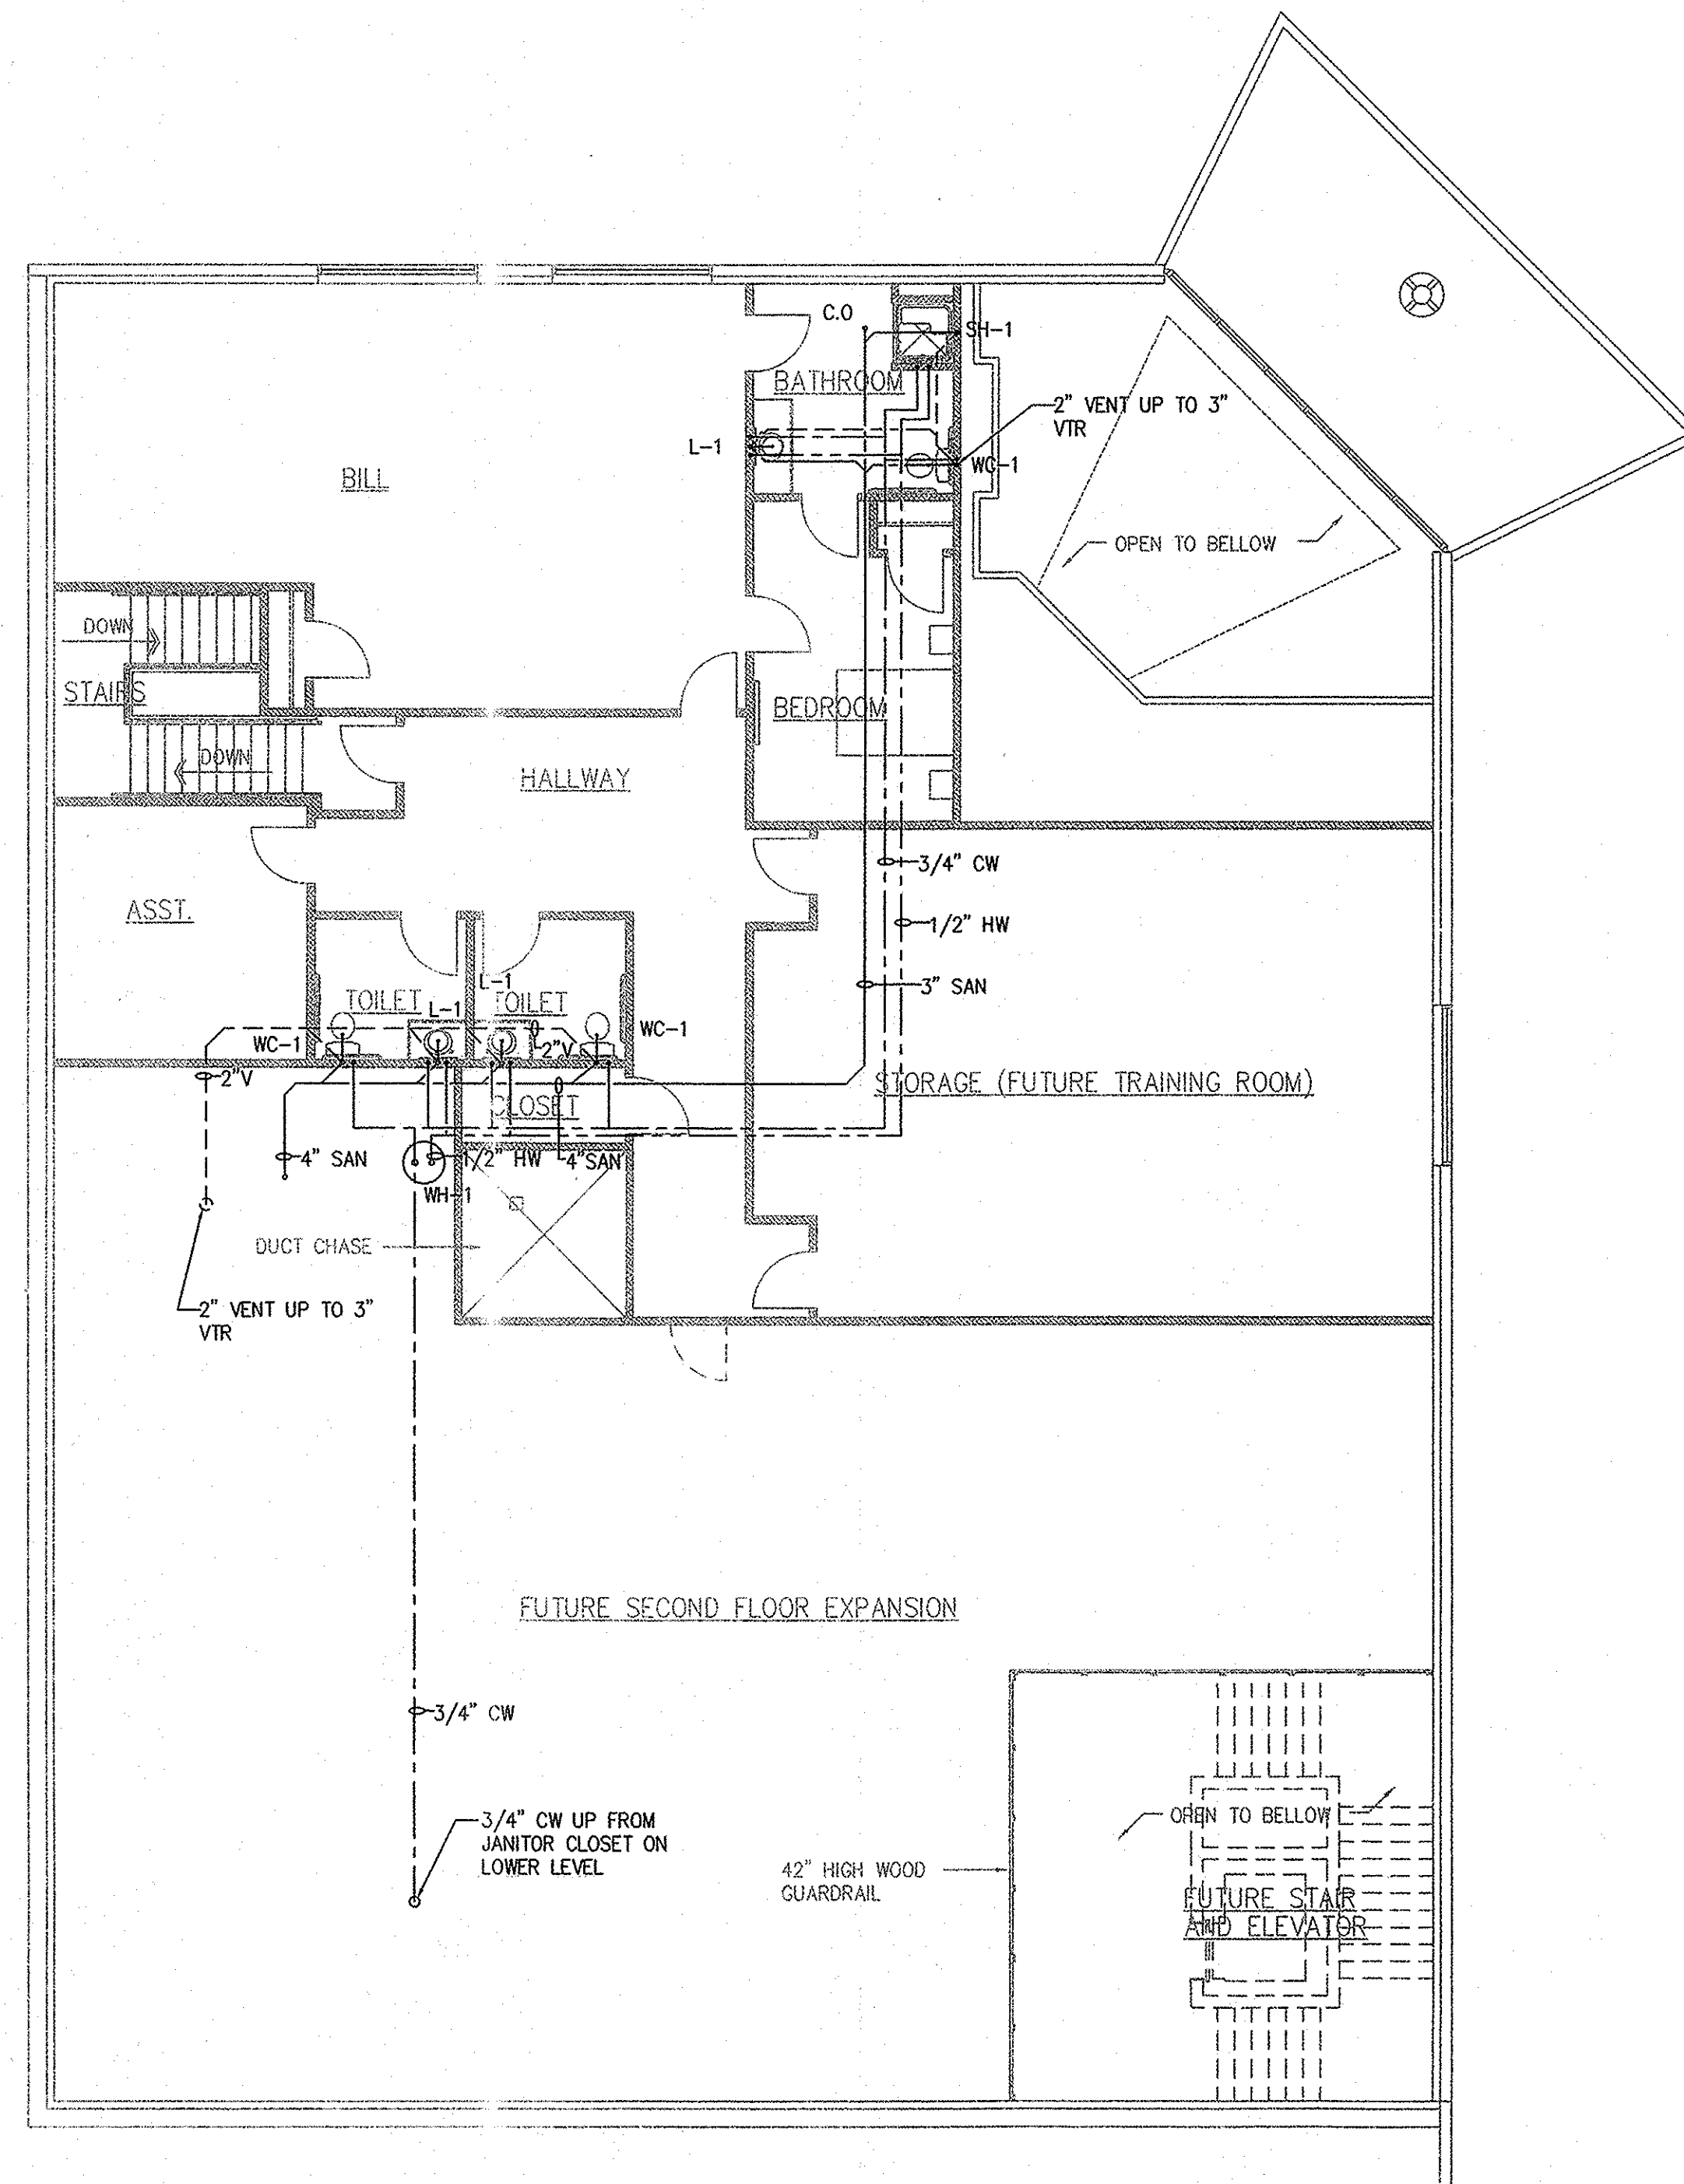

PARTIAL MEZZANINE FLOOR PLAN – INTERIOR FITOUT
SCALE: 1/8"=1'-0"
MEZZANINE FITOUT AREA: 2,980 SQ. FT.

FOR CONSTRUCTION

REVISIONS	
NO.	DESCRIPTION
1	DATE
2	
3	
4	
5	
6	
7	
8	
9	
10	

James E. Baumgardner
A R C H I T E C T
141 Broadway, Suite 220, Hanover, Pa. 17331
TEL: 717-637-6720 • FAX: 717-637-9178

CONEWAGO
ENTERPRISES, INC.
660 Edgemoor Road, P.O. Box 407, Hanover, PA 17331
Phone (717) 632-7722, FAX (717) 632-8886

INTERIOR FIT OUT
APPALACHIAN INSULATION INC.
22 BLACK HAWK LANE
ELIZABETHTOWN, PA. 17022

PLUMBING FLOOR PLANS

PROJECT: 1217	DRAWN BY: MPJ
DATE: 09/10/12	SCALE: AS NOTED
P-1	
JOB No. 3316	