

© GREENFIELD ARCHITECTS, LTD.
These plans are copyrighted and are
not to be reproduced, stored in a
retrieval system, or transmitted in
any form or by any means, electronic,
mechanical, photocopying, recording,
or by any information storage and
retrieval system, without the prior
written permission of Greenfield
Architects, Ltd. Any reproduction of
this document in part or whole without
the express written permission of
Greenfield Architects, Ltd. is
strictly prohibited.

MARK	DATE	BY	CHK	RELEASE
1	6-22-02	RS	KD	BULLETIN #1
2	7-22-02	MJD	KD	BULLETIN #2
3	12-15-02	DHS	KD	BULLETIN #6
4	02-12-03	MJD	KD	BULLETIN #7

GREENFIELD ARCHITECTS, LTD.
An Affiliate of the High Real Estate Group
1553 William Penn Way • P.O. Box 10008 • Lancaster, PA 17605-0008
(717) 293-4475 • FAX (717) 293-4451



HIGH CONSTRUCTION
1553 William Penn Way • P.O. Box 10008 • Lancaster, PA 17605-0008
(717) 293-4475 • FAX (717) 293-4451

OFFICE / WAREHOUSE FACILITY
SUPPLY, INCORPORATED
CONEWAGO INDUSTRIAL PARK - LOT 12
WEST DONNEGAL TOWNSHIP
ELIZABETHTOWN, PA 17022


SCALE	AS SHOWN	DATE	02-12-03
DRAWN	MJD	CHECKED	KD

PROJECT # 01110

OVERALL FLOOR
PLAN - CODES

A-003

CODE PLAN LEGEND	
FE	FIRE EXTINGUISHER
FE.C.	FIRE EXTINGUISHER CABINET
EXIT	EXIT SIGN LIGHT FIXTURE
EXIT	EMERGENCY LIGHT FIXTURE WITH BATTERY PACK
XX	TRAVEL DISTANCE (FT) AND ROUTE OF EXIT ACCESS
---	1 HOUR FIRE RESISTANCE RATED CONSTRUCTION

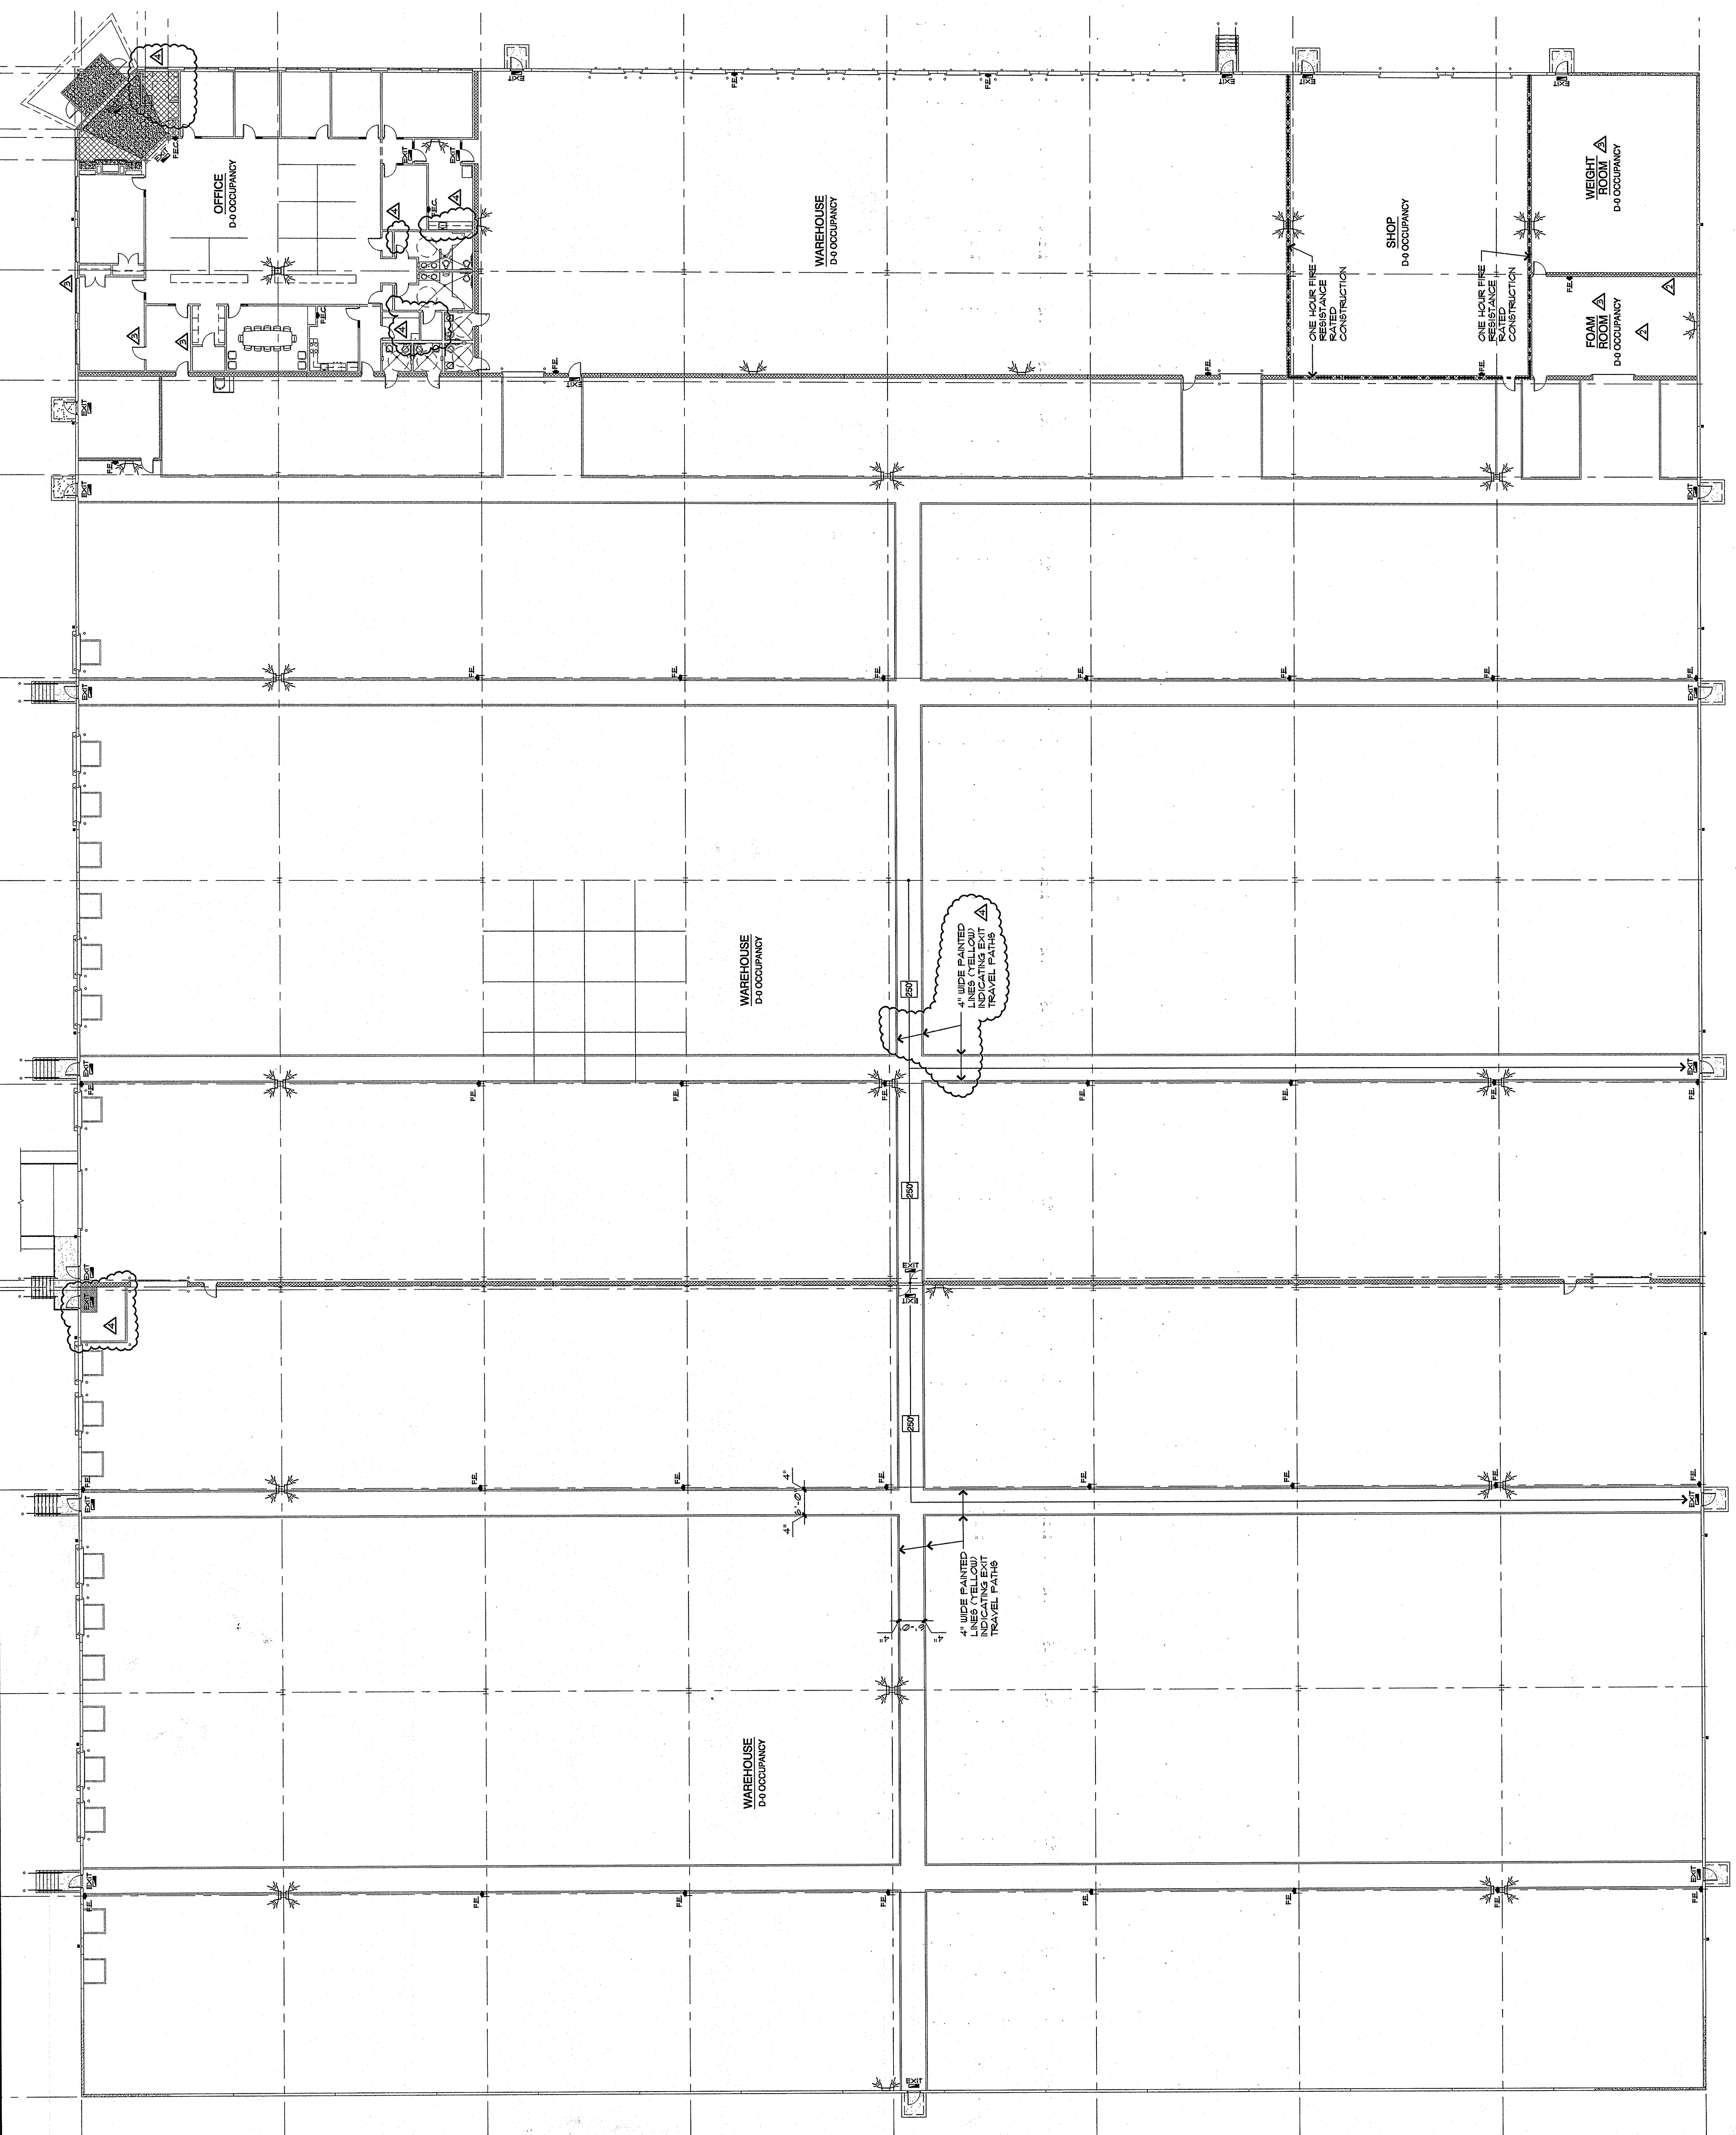

1 OVERALL FLOOR PLAN - CODES
1/16"=1'-0"